

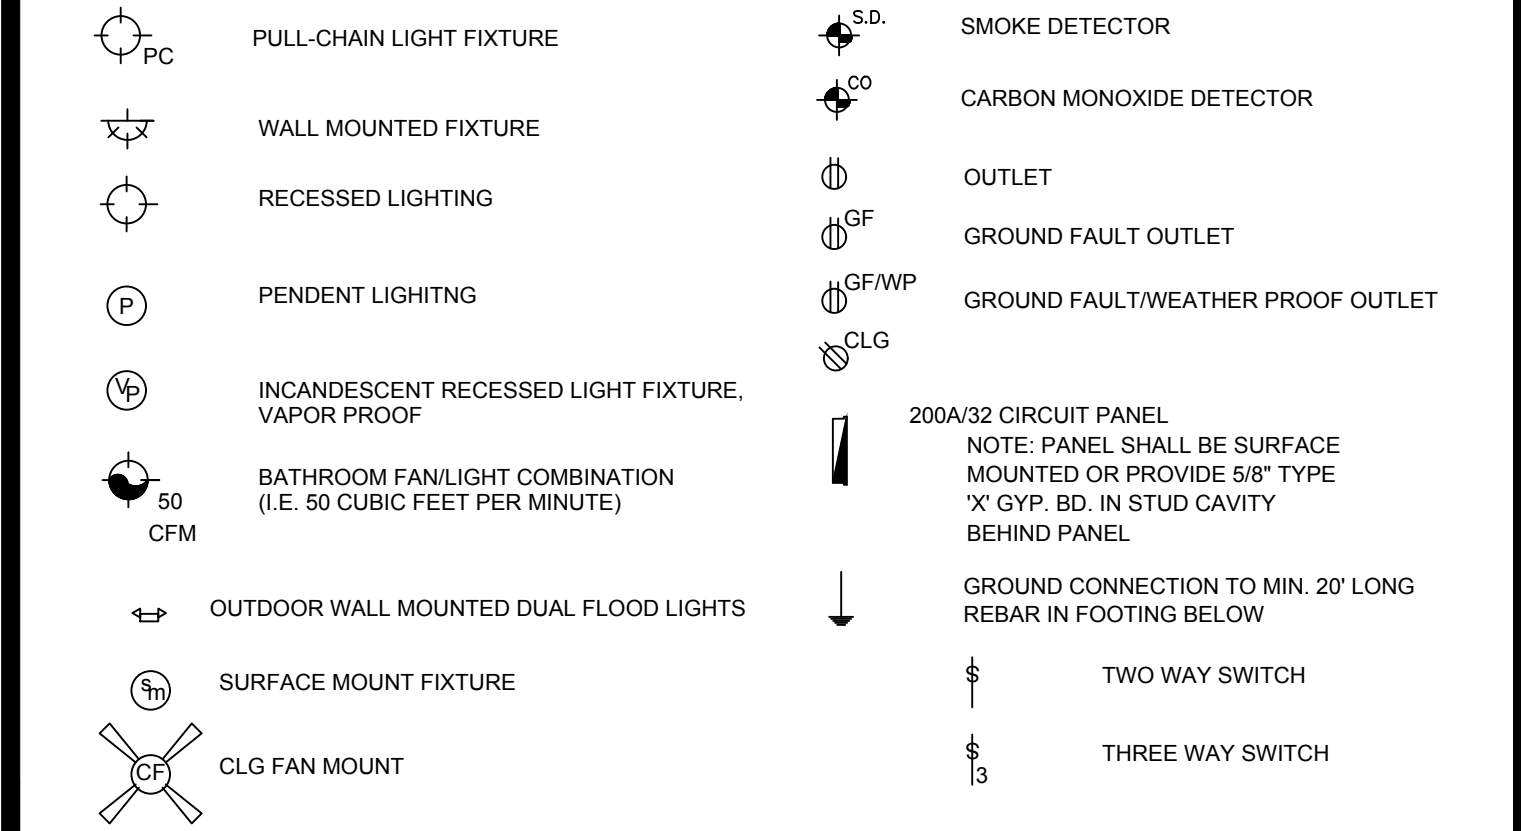
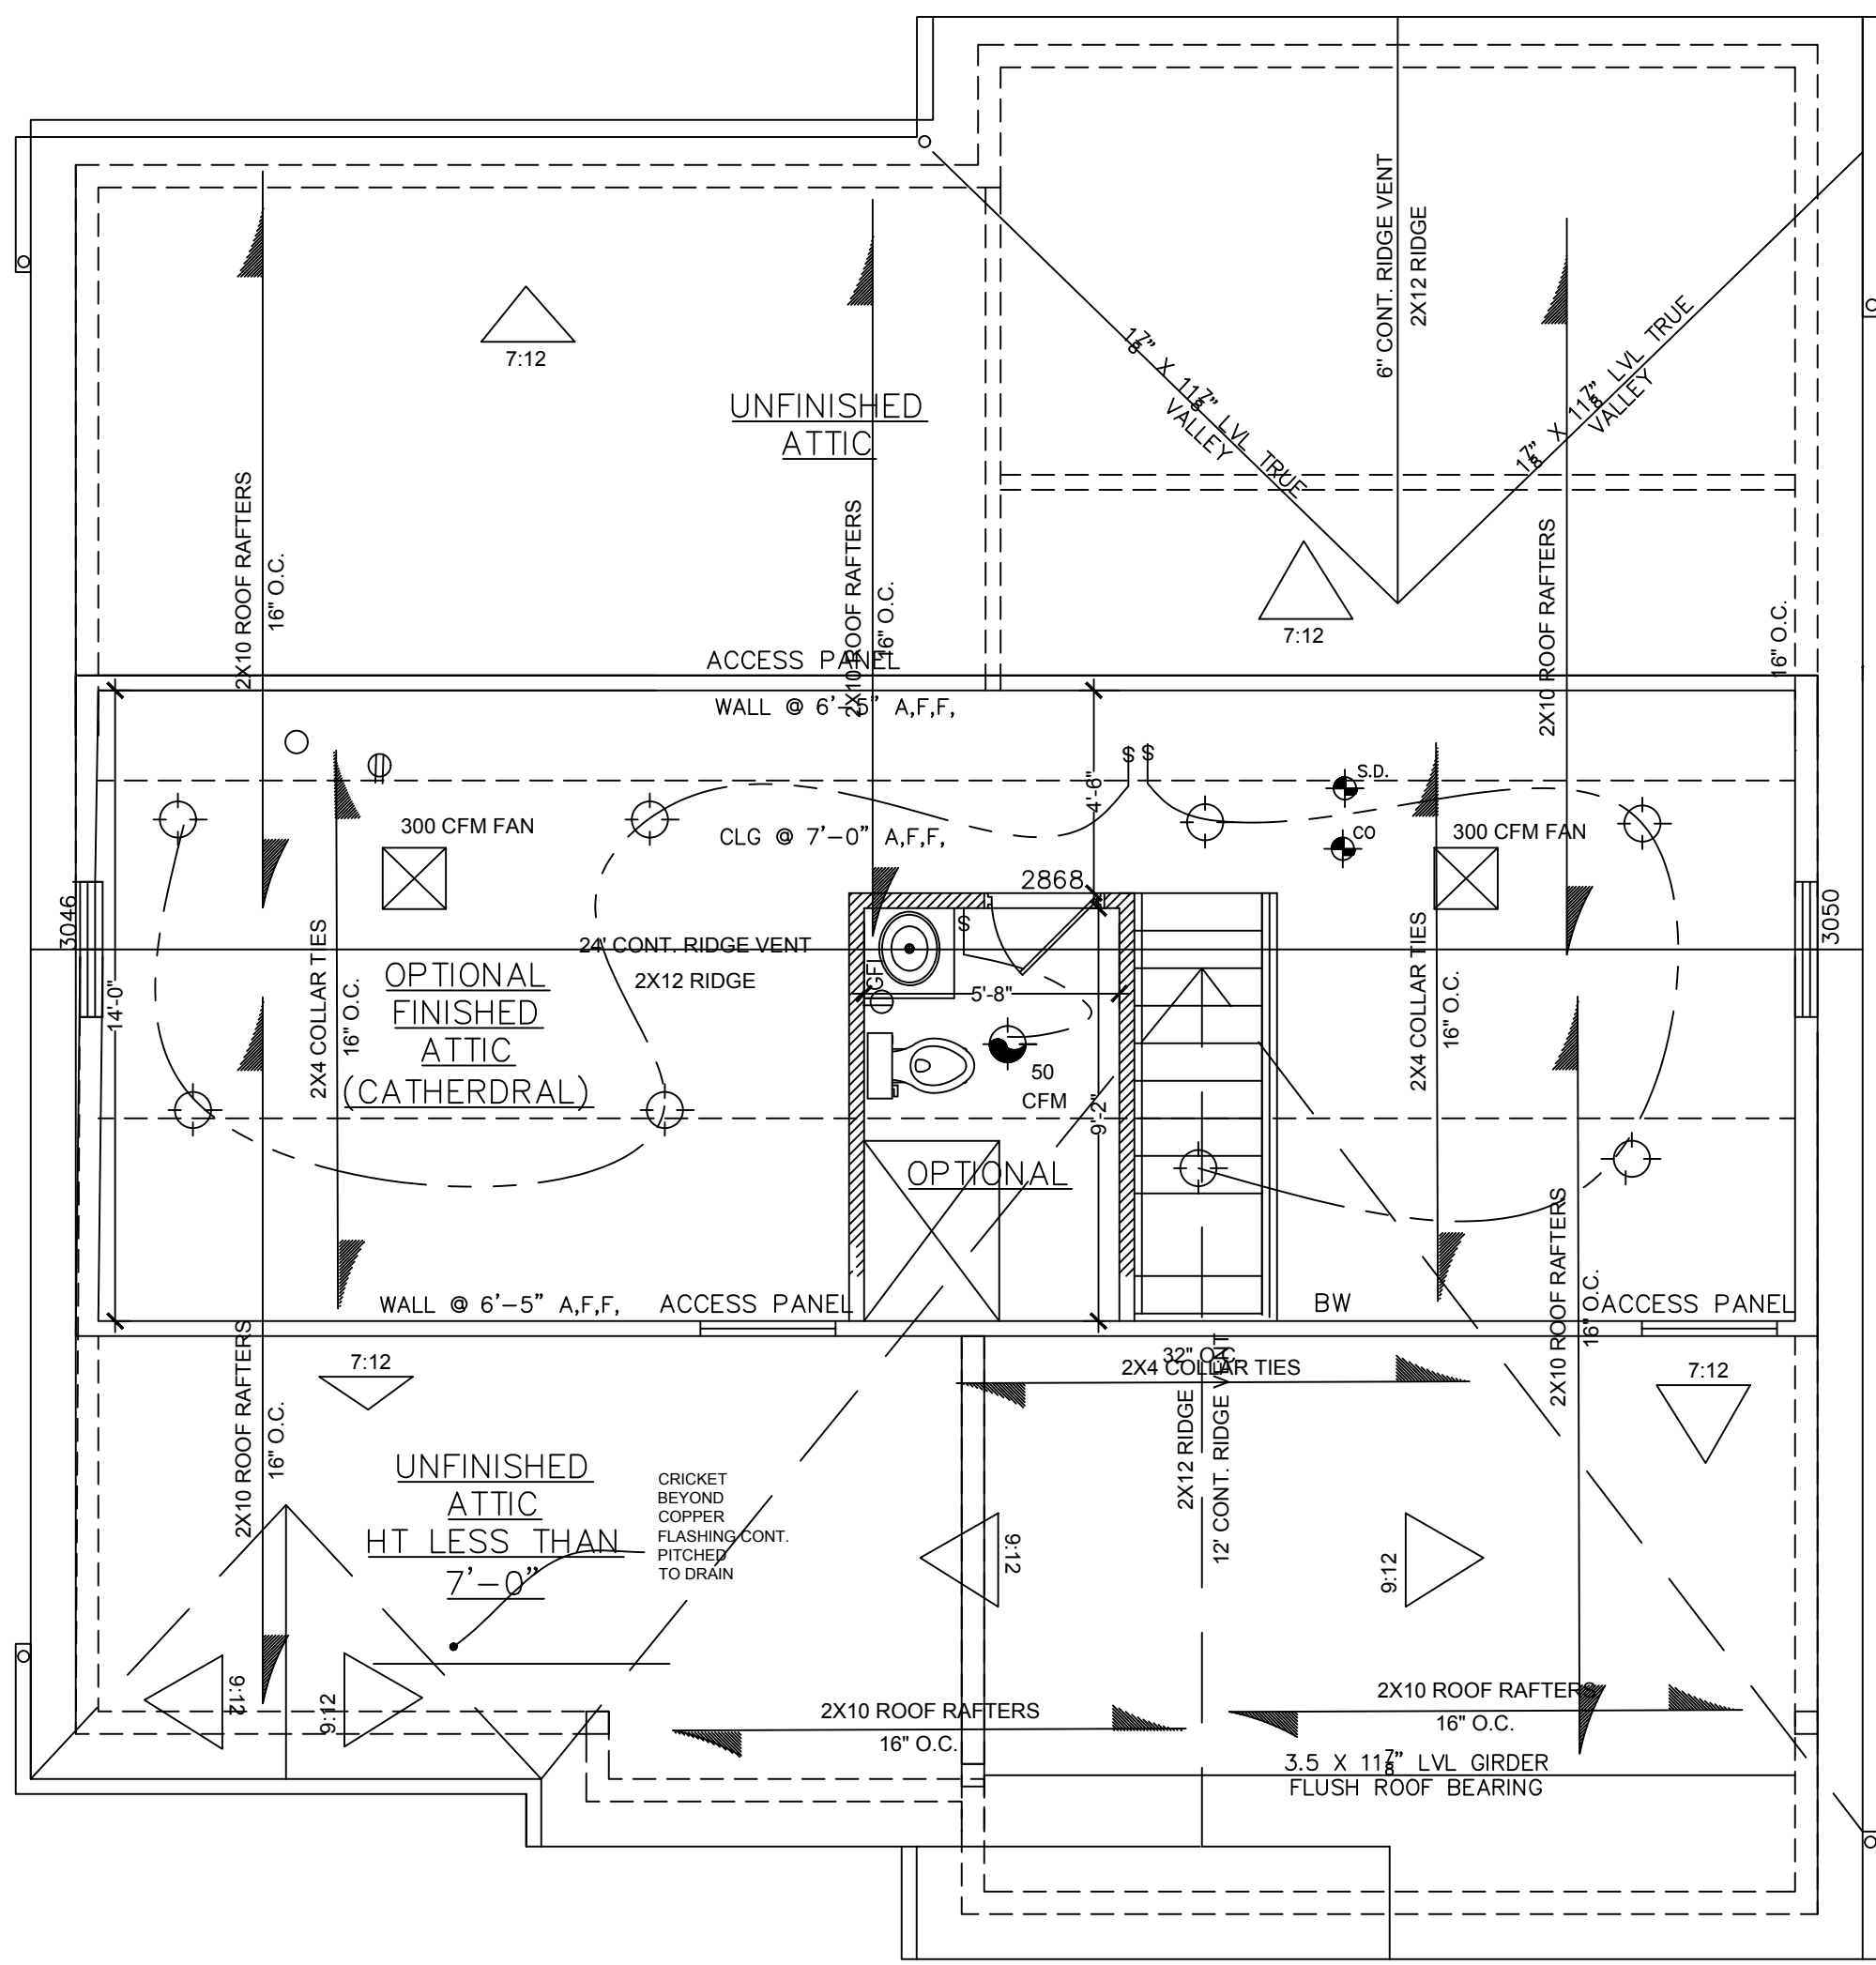


ELECTRICAL LEGEND

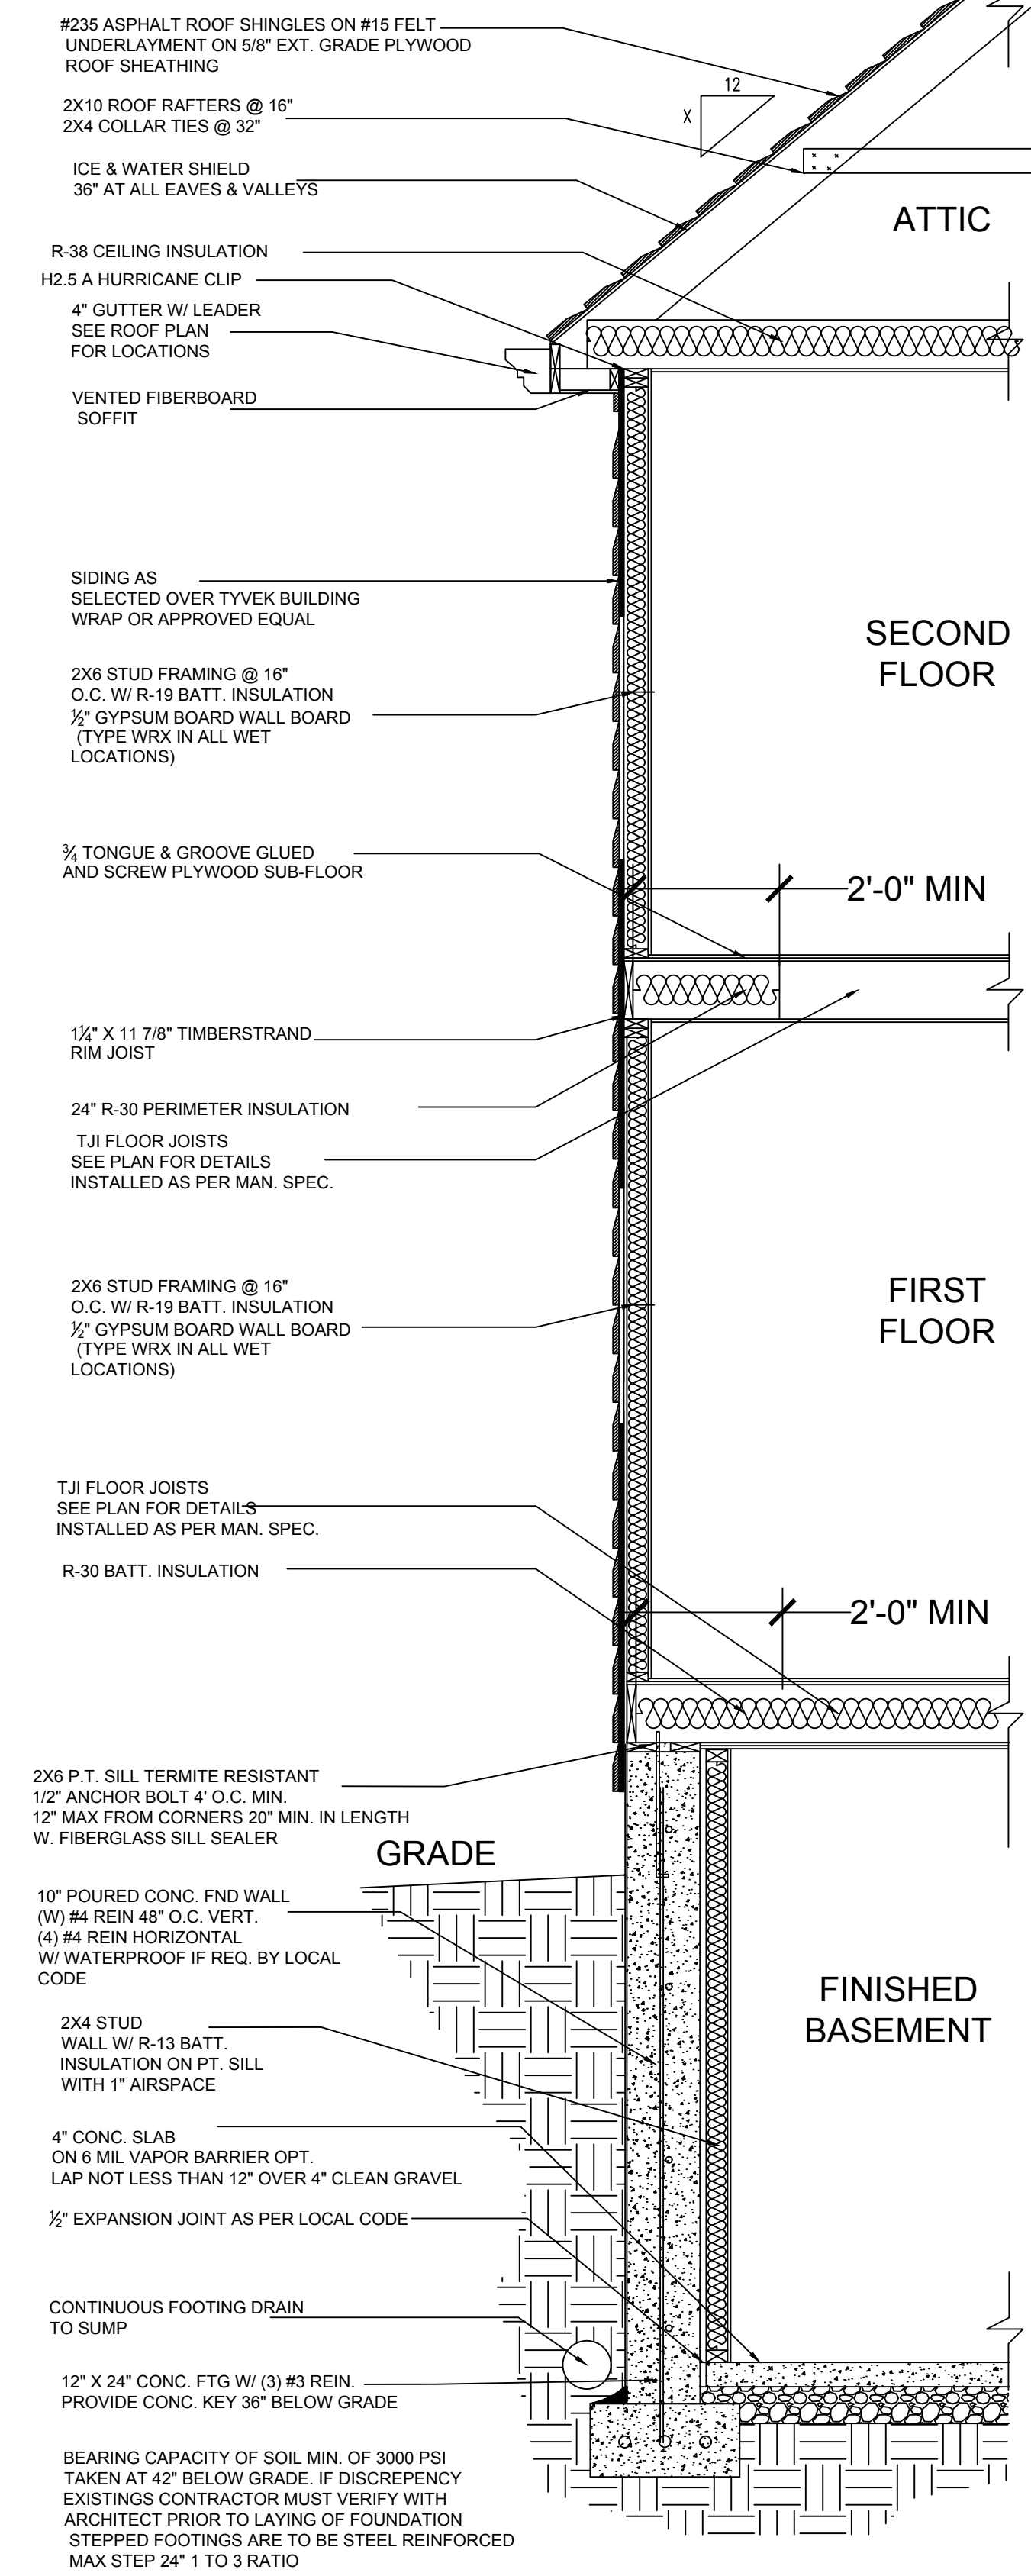


ATTIC SECTION

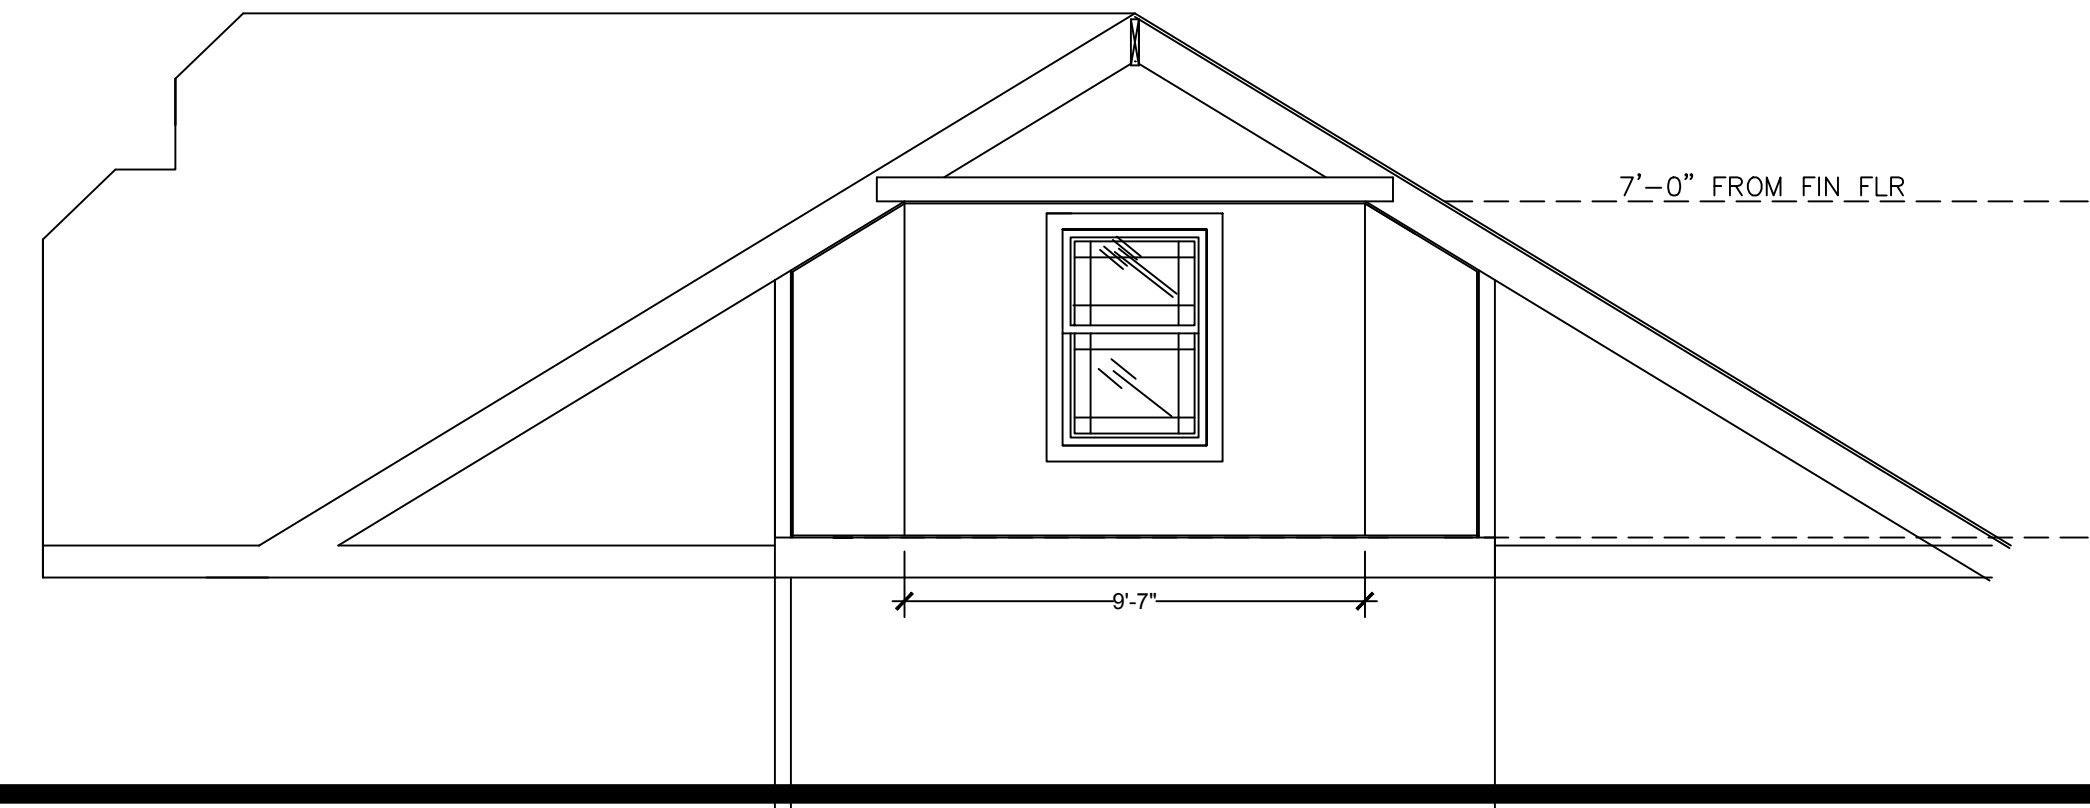

ROOF/ATTIC PLAN

Scale: 1/4" = 1'-0"

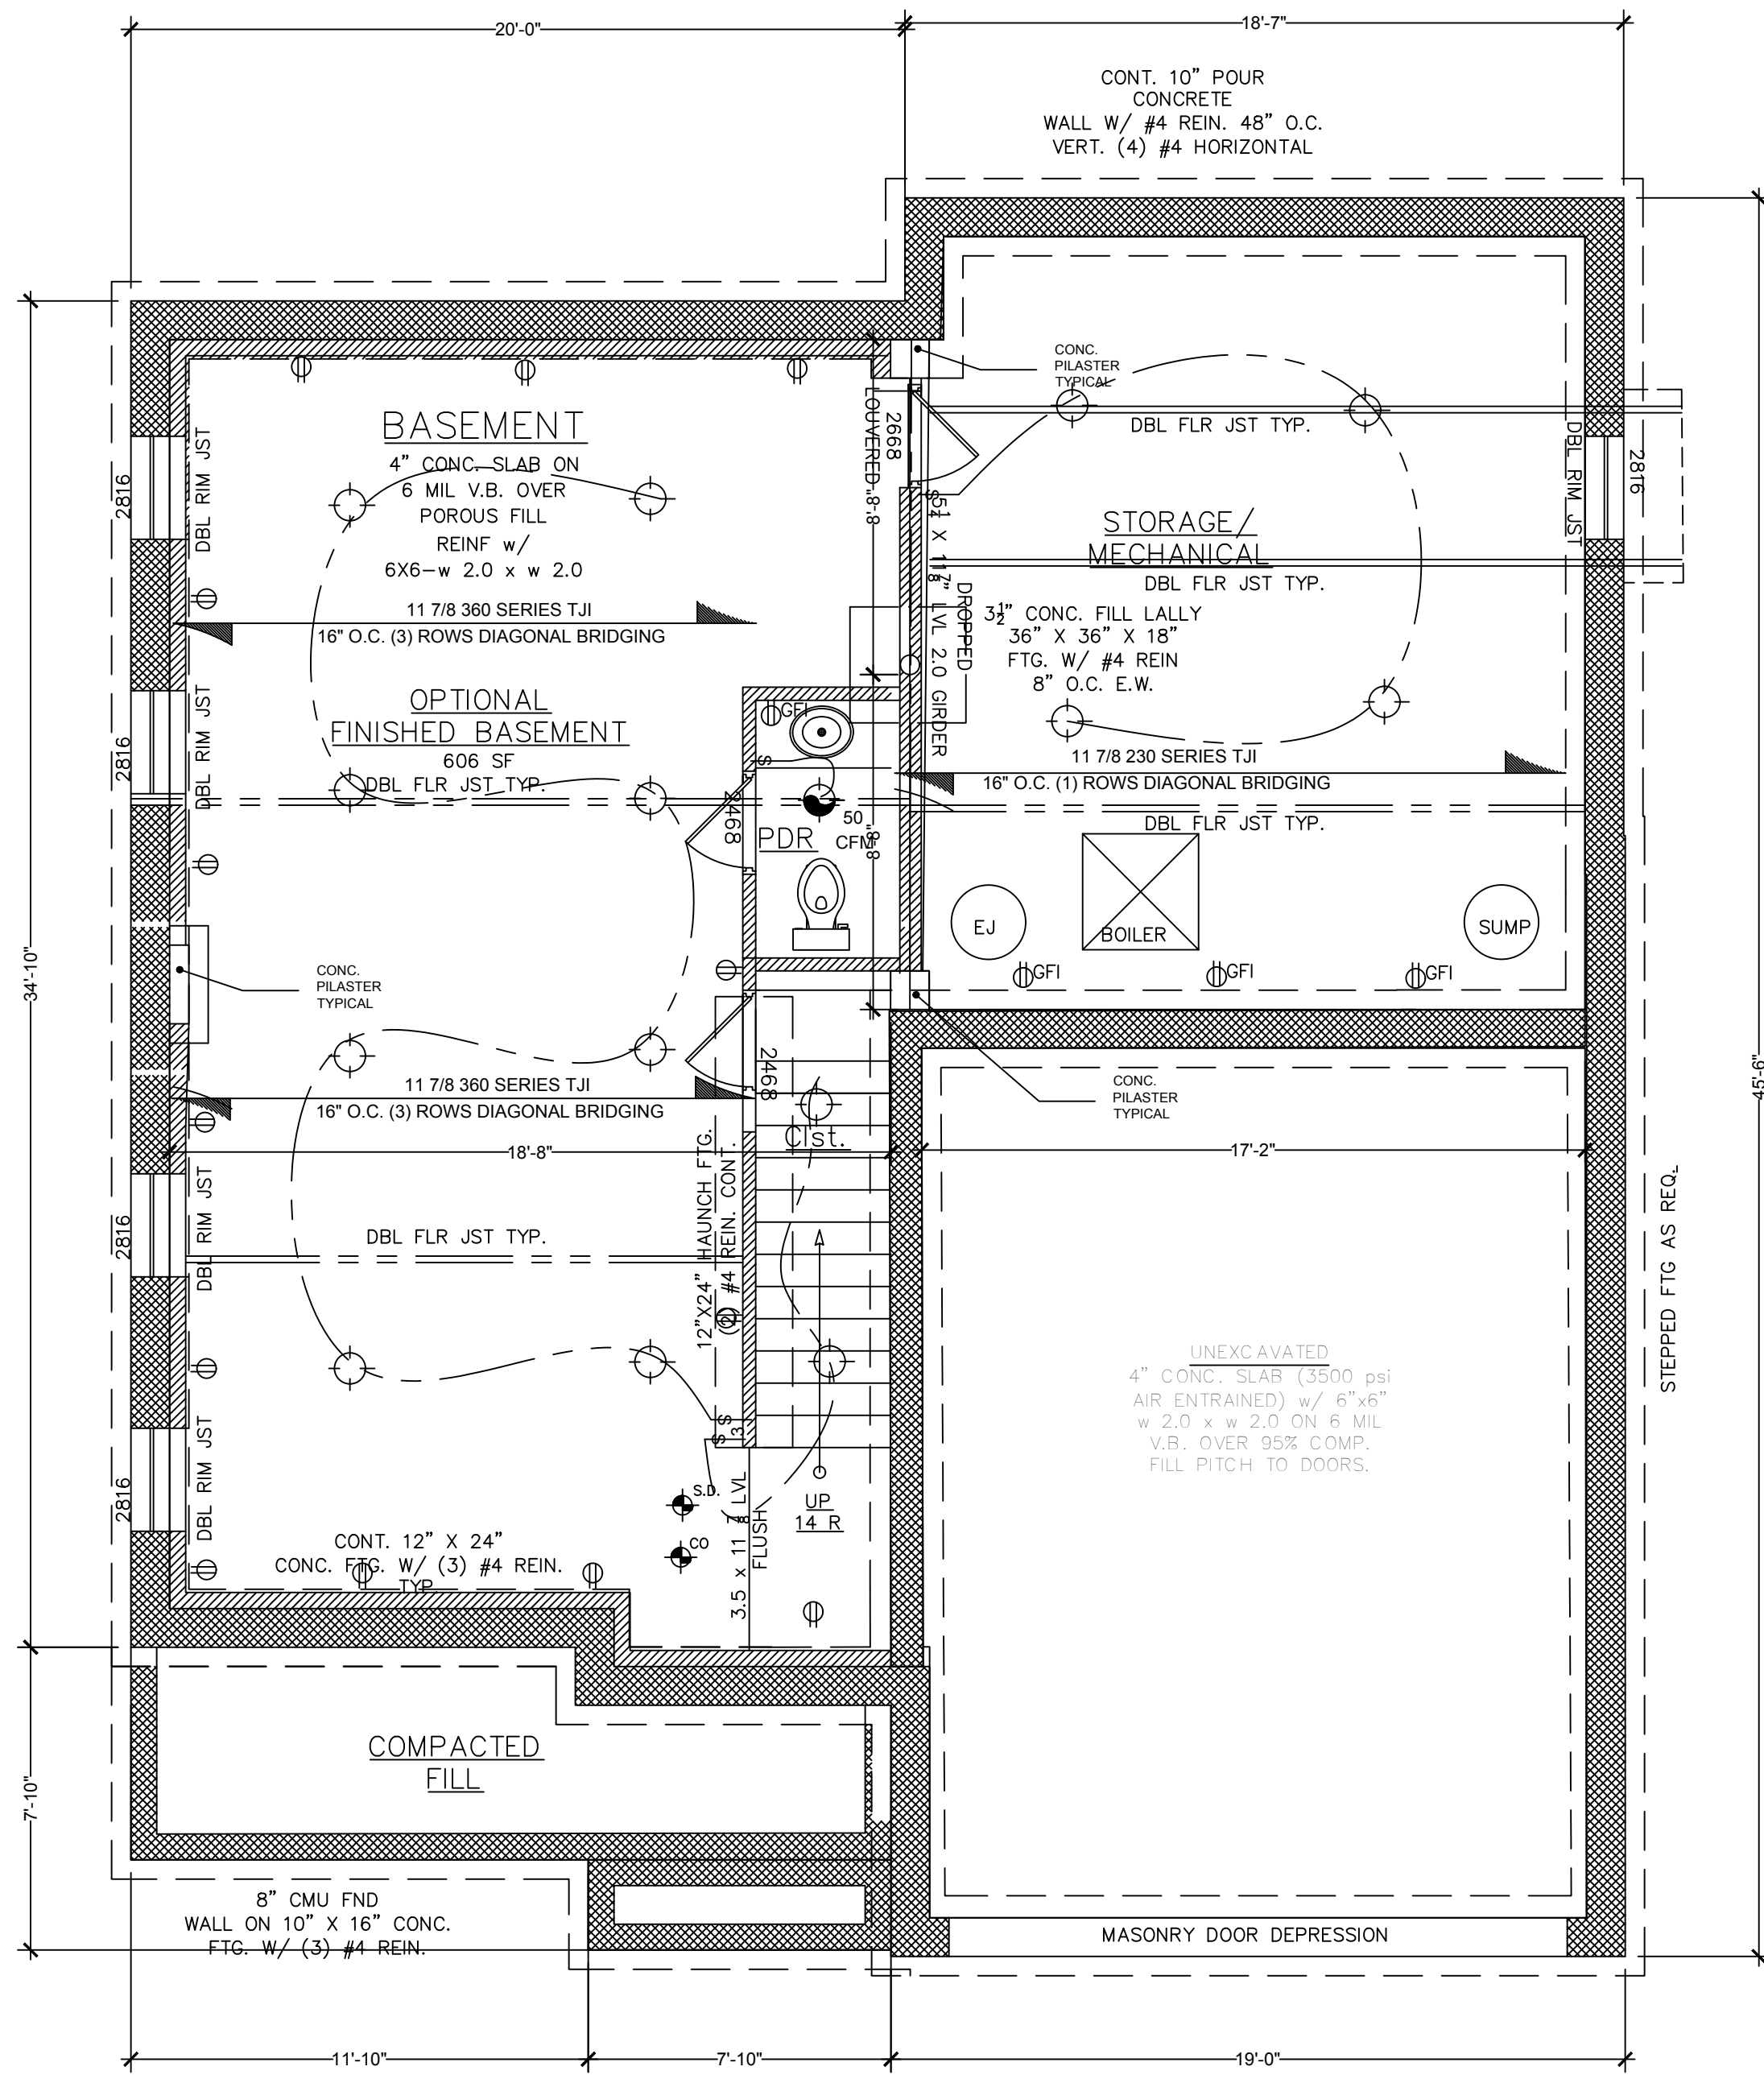


FOUNDATION/BASEMENT PLAN

Scale: 1/4" = 1'-0"

TYPICAL WALL SECTION

1/2" = 1'-0"

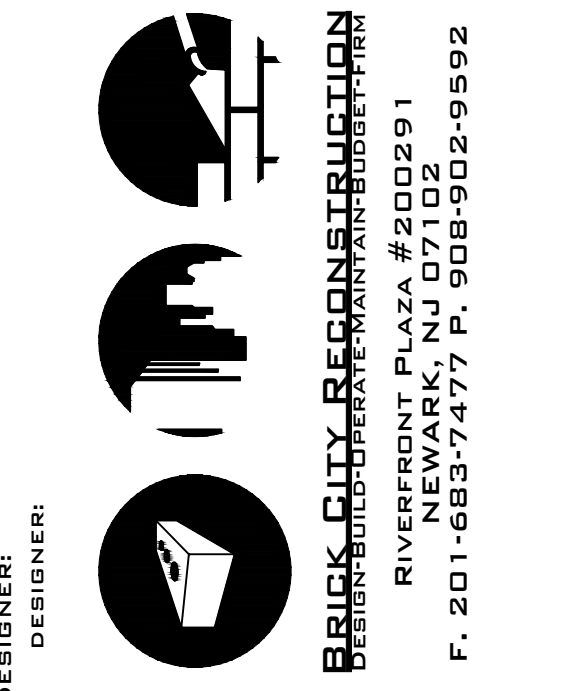

DESIGNER: DESIGNER:

PATRICK M. LESBIREL
ARCHITECT
NJ LICENSE NO. A120605

SUBMISSIONS

NO.	DESCRIPTION	DATE

THESE DRAWINGS, OR PARTS THEREOF, MAY NOT BE UTILIZED OR REPRODUCED IN ANY FORM, BY ANY METHOD, FOR ANY PURPOSE, WITHOUT THE PRIOR WRITTEN CONSENT FROM PATRICK M. LESBIREL, ARCHITECT. THESE DRAWINGS SHALL ONLY BE USED FOR THE SPECIFIC PROJECT LOCATION INDICATED WITHIN THE TITLE BLOCK.

REVISIONS

NO.	DESCRIPTION	DATE

PROJECT:

LOCUST STREET

LOCATION:

ABERDEEN, NJ

TITLE:

FND PLAN

ROOF PLAN


WALL SECT.

SCALE: AS NOTED
DATE: 1.25.2016
DRAWN: P.M.L
CHECKED: P.V.G.
JOB NO.: 15247
SHEET: 2 OF 4

DRAWING:


A-02

ELECTRICAL LEGEND			
	PULL-CHAIN LIGHT FIXTURE		SMOKE DETECTOR
	WALL MOUNTED FIXTURE		CARBON MONOXIDE DETECTOR
	RECESSED LIGHTING		OUTLET
	PENDENT LIGHTING		GROUND FAULT OUTLET
	INCANDESCENT RECESSED LIGHT FIXTURE, VAPOR PROOF		GROUND FAULT/WEATHER PROOF OUTLET
	BATHROOM FANLIGHT COMBINATION (I.E. 50 CUBIC FEET PER MINUTE)		200A/32 CIRCUIT PANEL NOTE: PANEL SHALL BE SURFACE MOUNTED OR PROVIDE 5/8" TYPE "X" GYP. BD. IN STUD CAVITY BEHIND PANEL
	OUTDOOR WALL MOUNTED DUAL FLOOD LIGHTS		GROUND CONNECTION TO MIN. 20" LONG REBAR IN FOOTING BELOW
	SURFACE MOUNT FIXTURE		TWO WAY SWITCH
	CLG FAN MOUNT		THREE WAY SWITCH

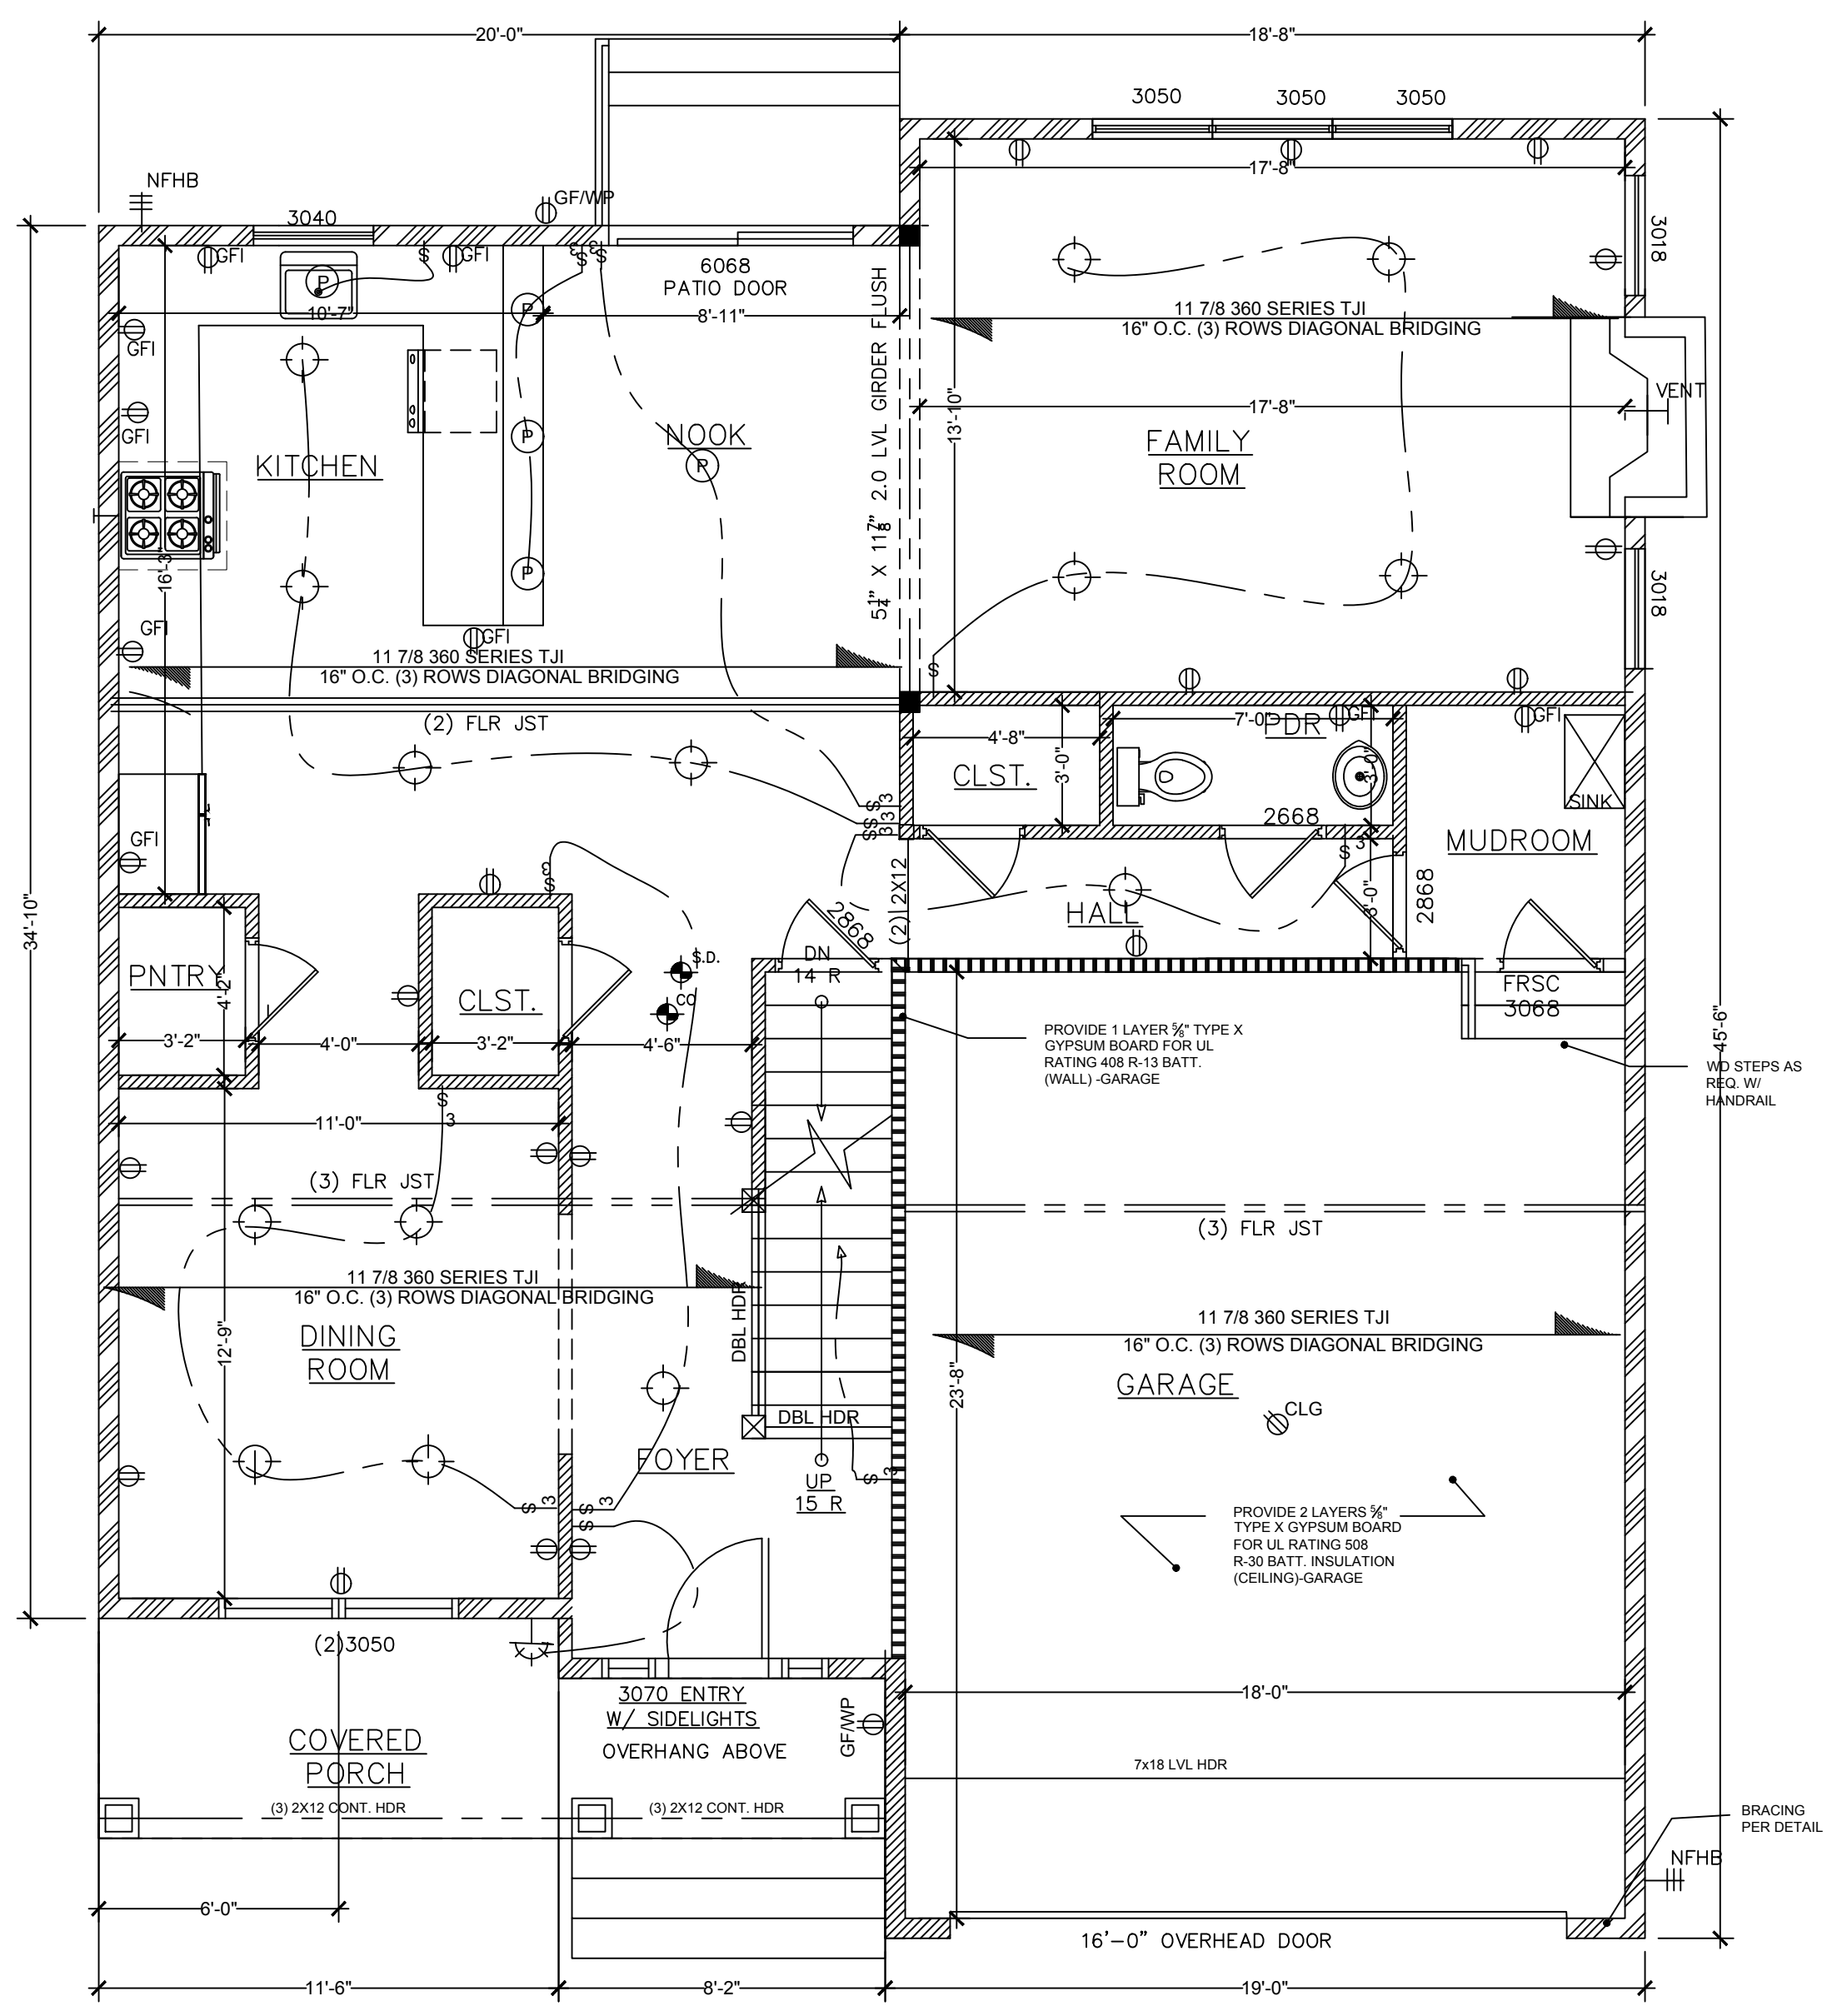


FIRST FLOOR PLAN
Scale: 1/4" = 1'-0"

WALL LEGEND	
	2x4 STUD FRAMING
	2x5 FIRERATED CONSTRUCTION
	2x6 STUD FRAMING

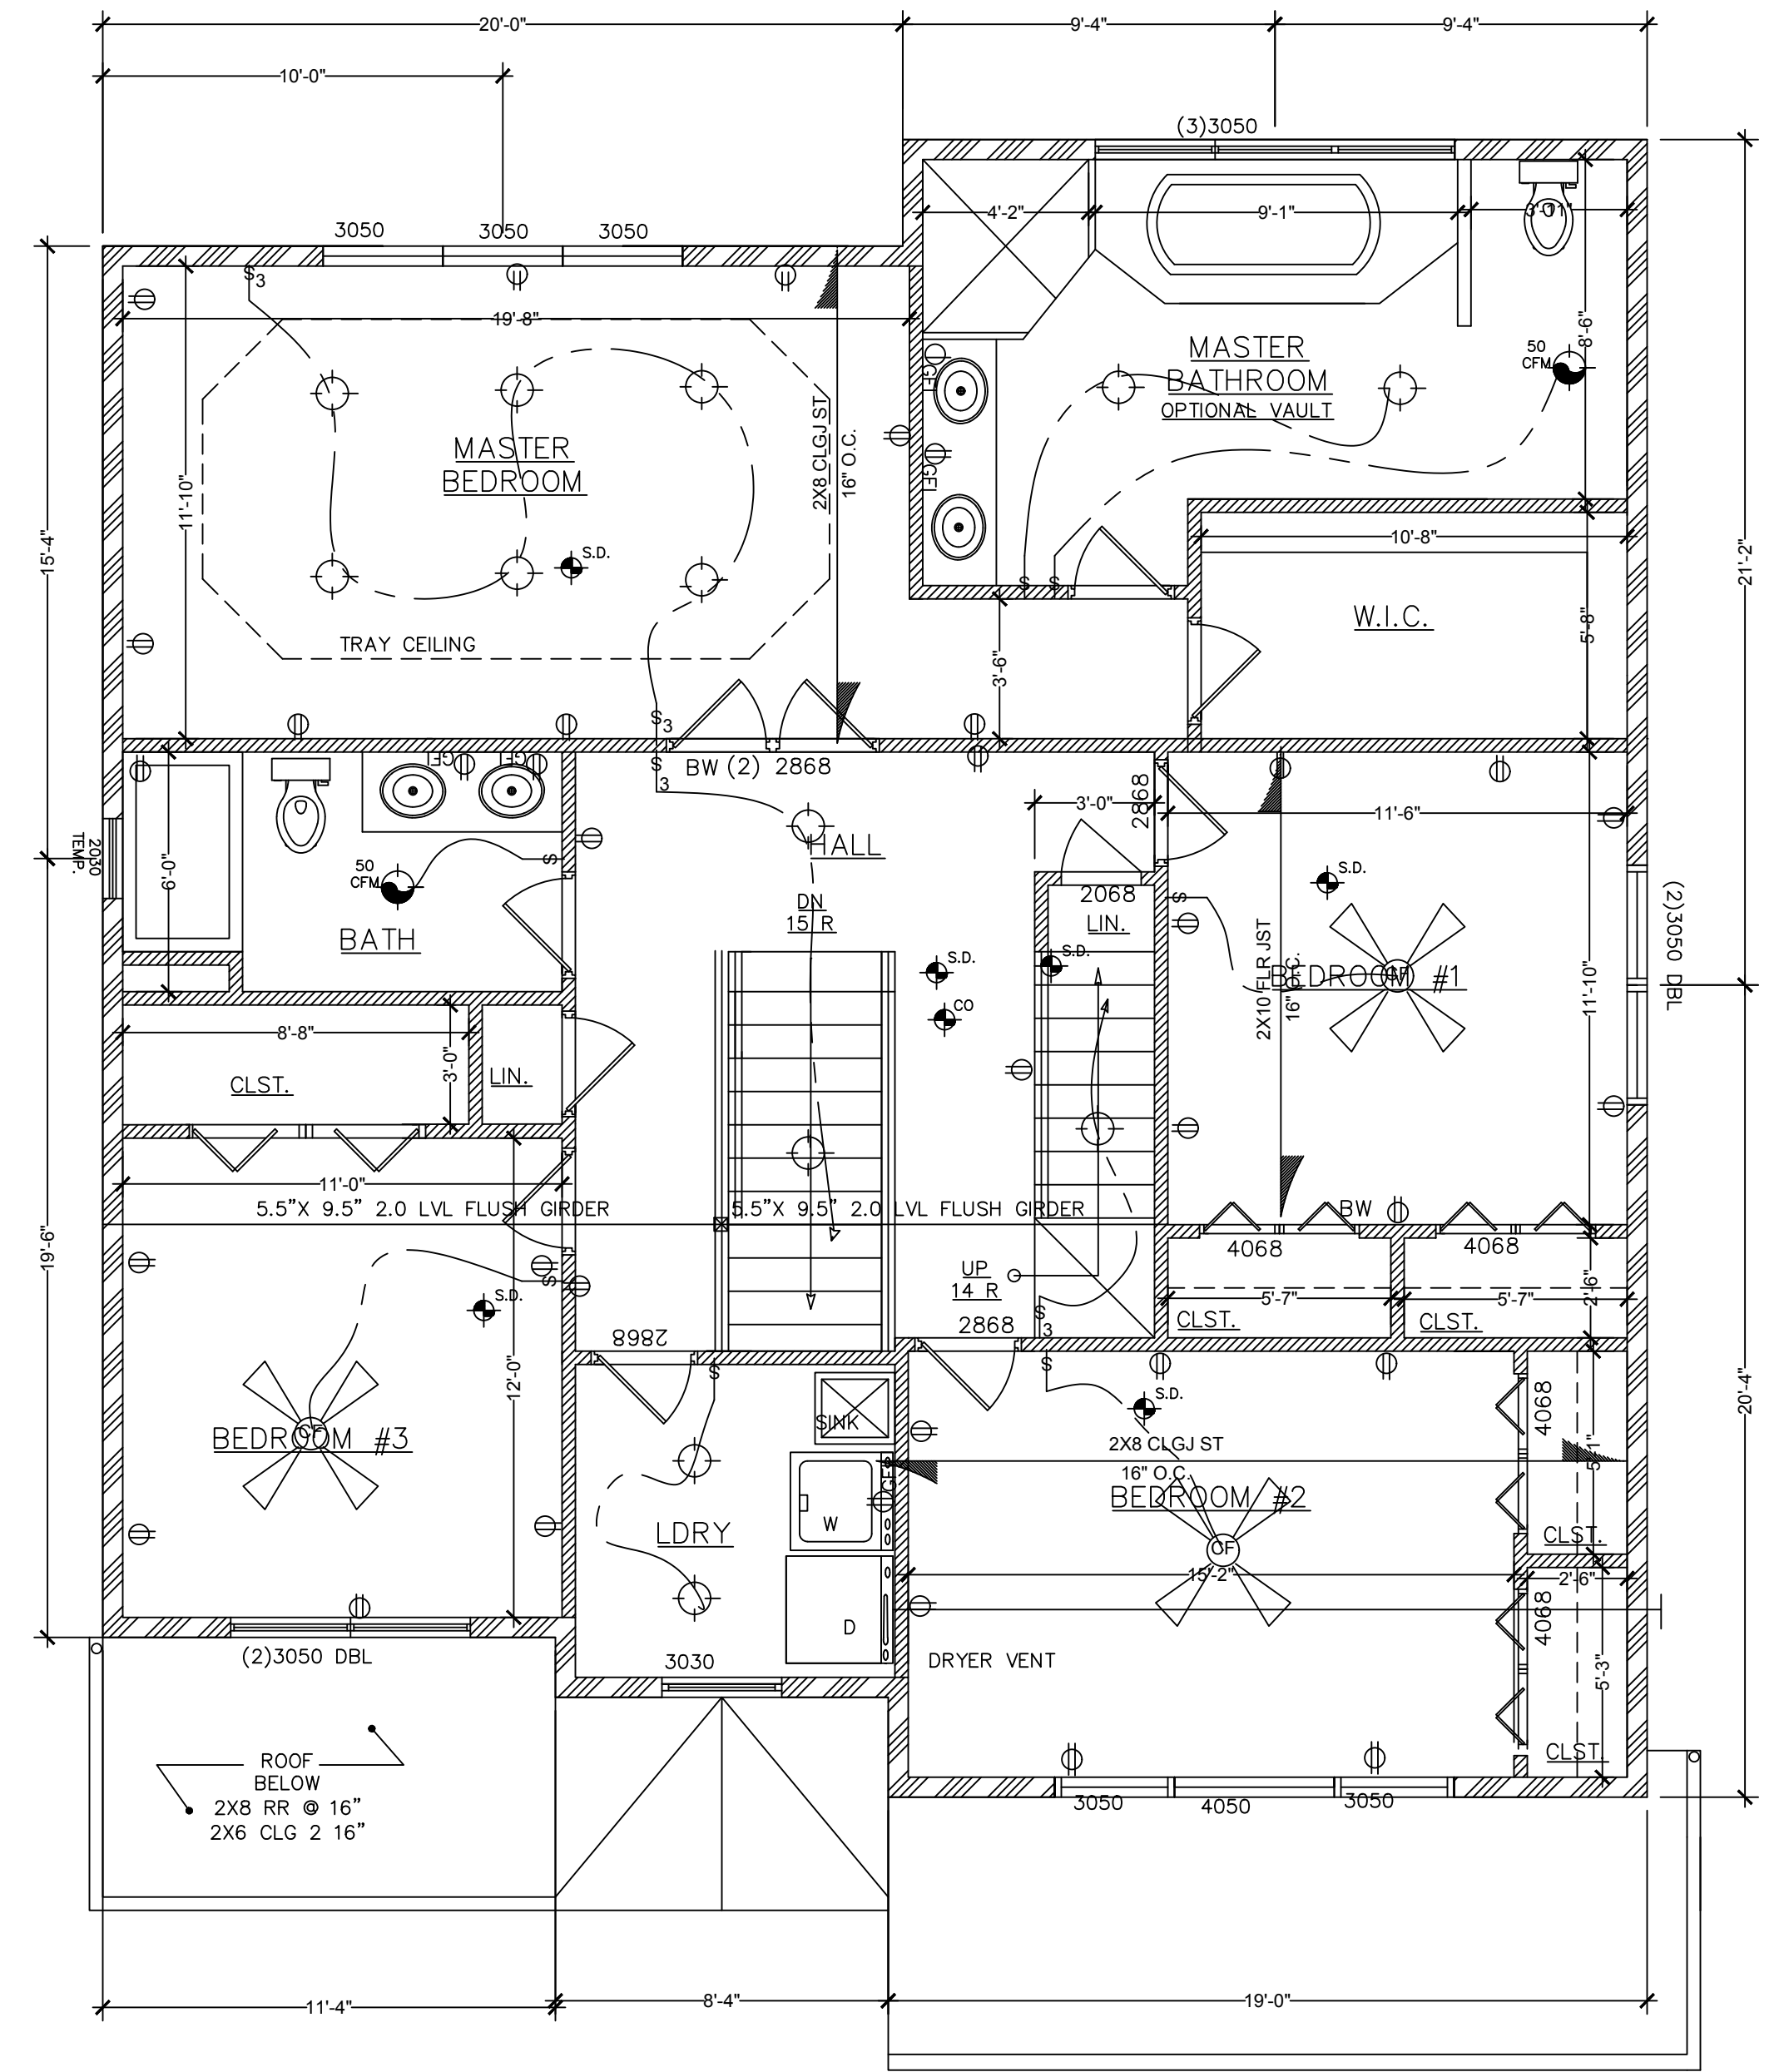

SECOND FLOOR PLAN
Scale: 1/4" = 1'-0"

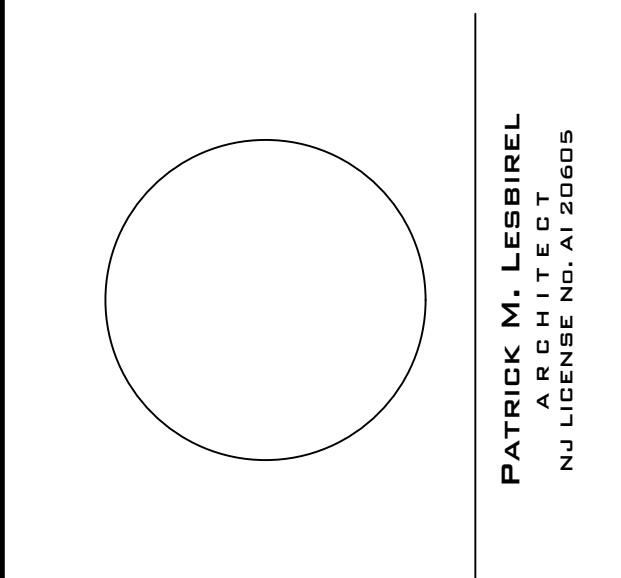

SUBMISSIONS		
NO.	DESCRIPTION	DATE

THESE DRAWINGS, OR PARTS THEREOF, MAY NOT BE UTILIZED OR REPRODUCED IN ANY FORM, BY ANY METHOD, FOR ANY PURPOSE, WITHOUT THE PRIOR WRITTEN CONSENT FROM PATRICK M. LESBIEREL, ARCHITECT. THESE DRAWINGS SHALL ONLY BE USED FOR THE SPECIFIC PROJECT LOCATION INDICATED WITHIN THE TITLE BLOCK.

REVISIONS		
NO.	DESCRIPTION	DATE

PROJECT:
LOCUST STREET

LOCATION:
ABERDEEN NJ


TITLE:
FIRST SECOND FLOOR PLANS

SCALE: AS NOTED
 DATE: 1.25.16
 DRAWN: P.M.L.
 CHECKED: P.V.G.
 JOB NO.: 15247
 SHEET: 2 OF 4


DRAWING:
A-03



FRONT ELEVATION
Scale: 1/4" = 1'-0"

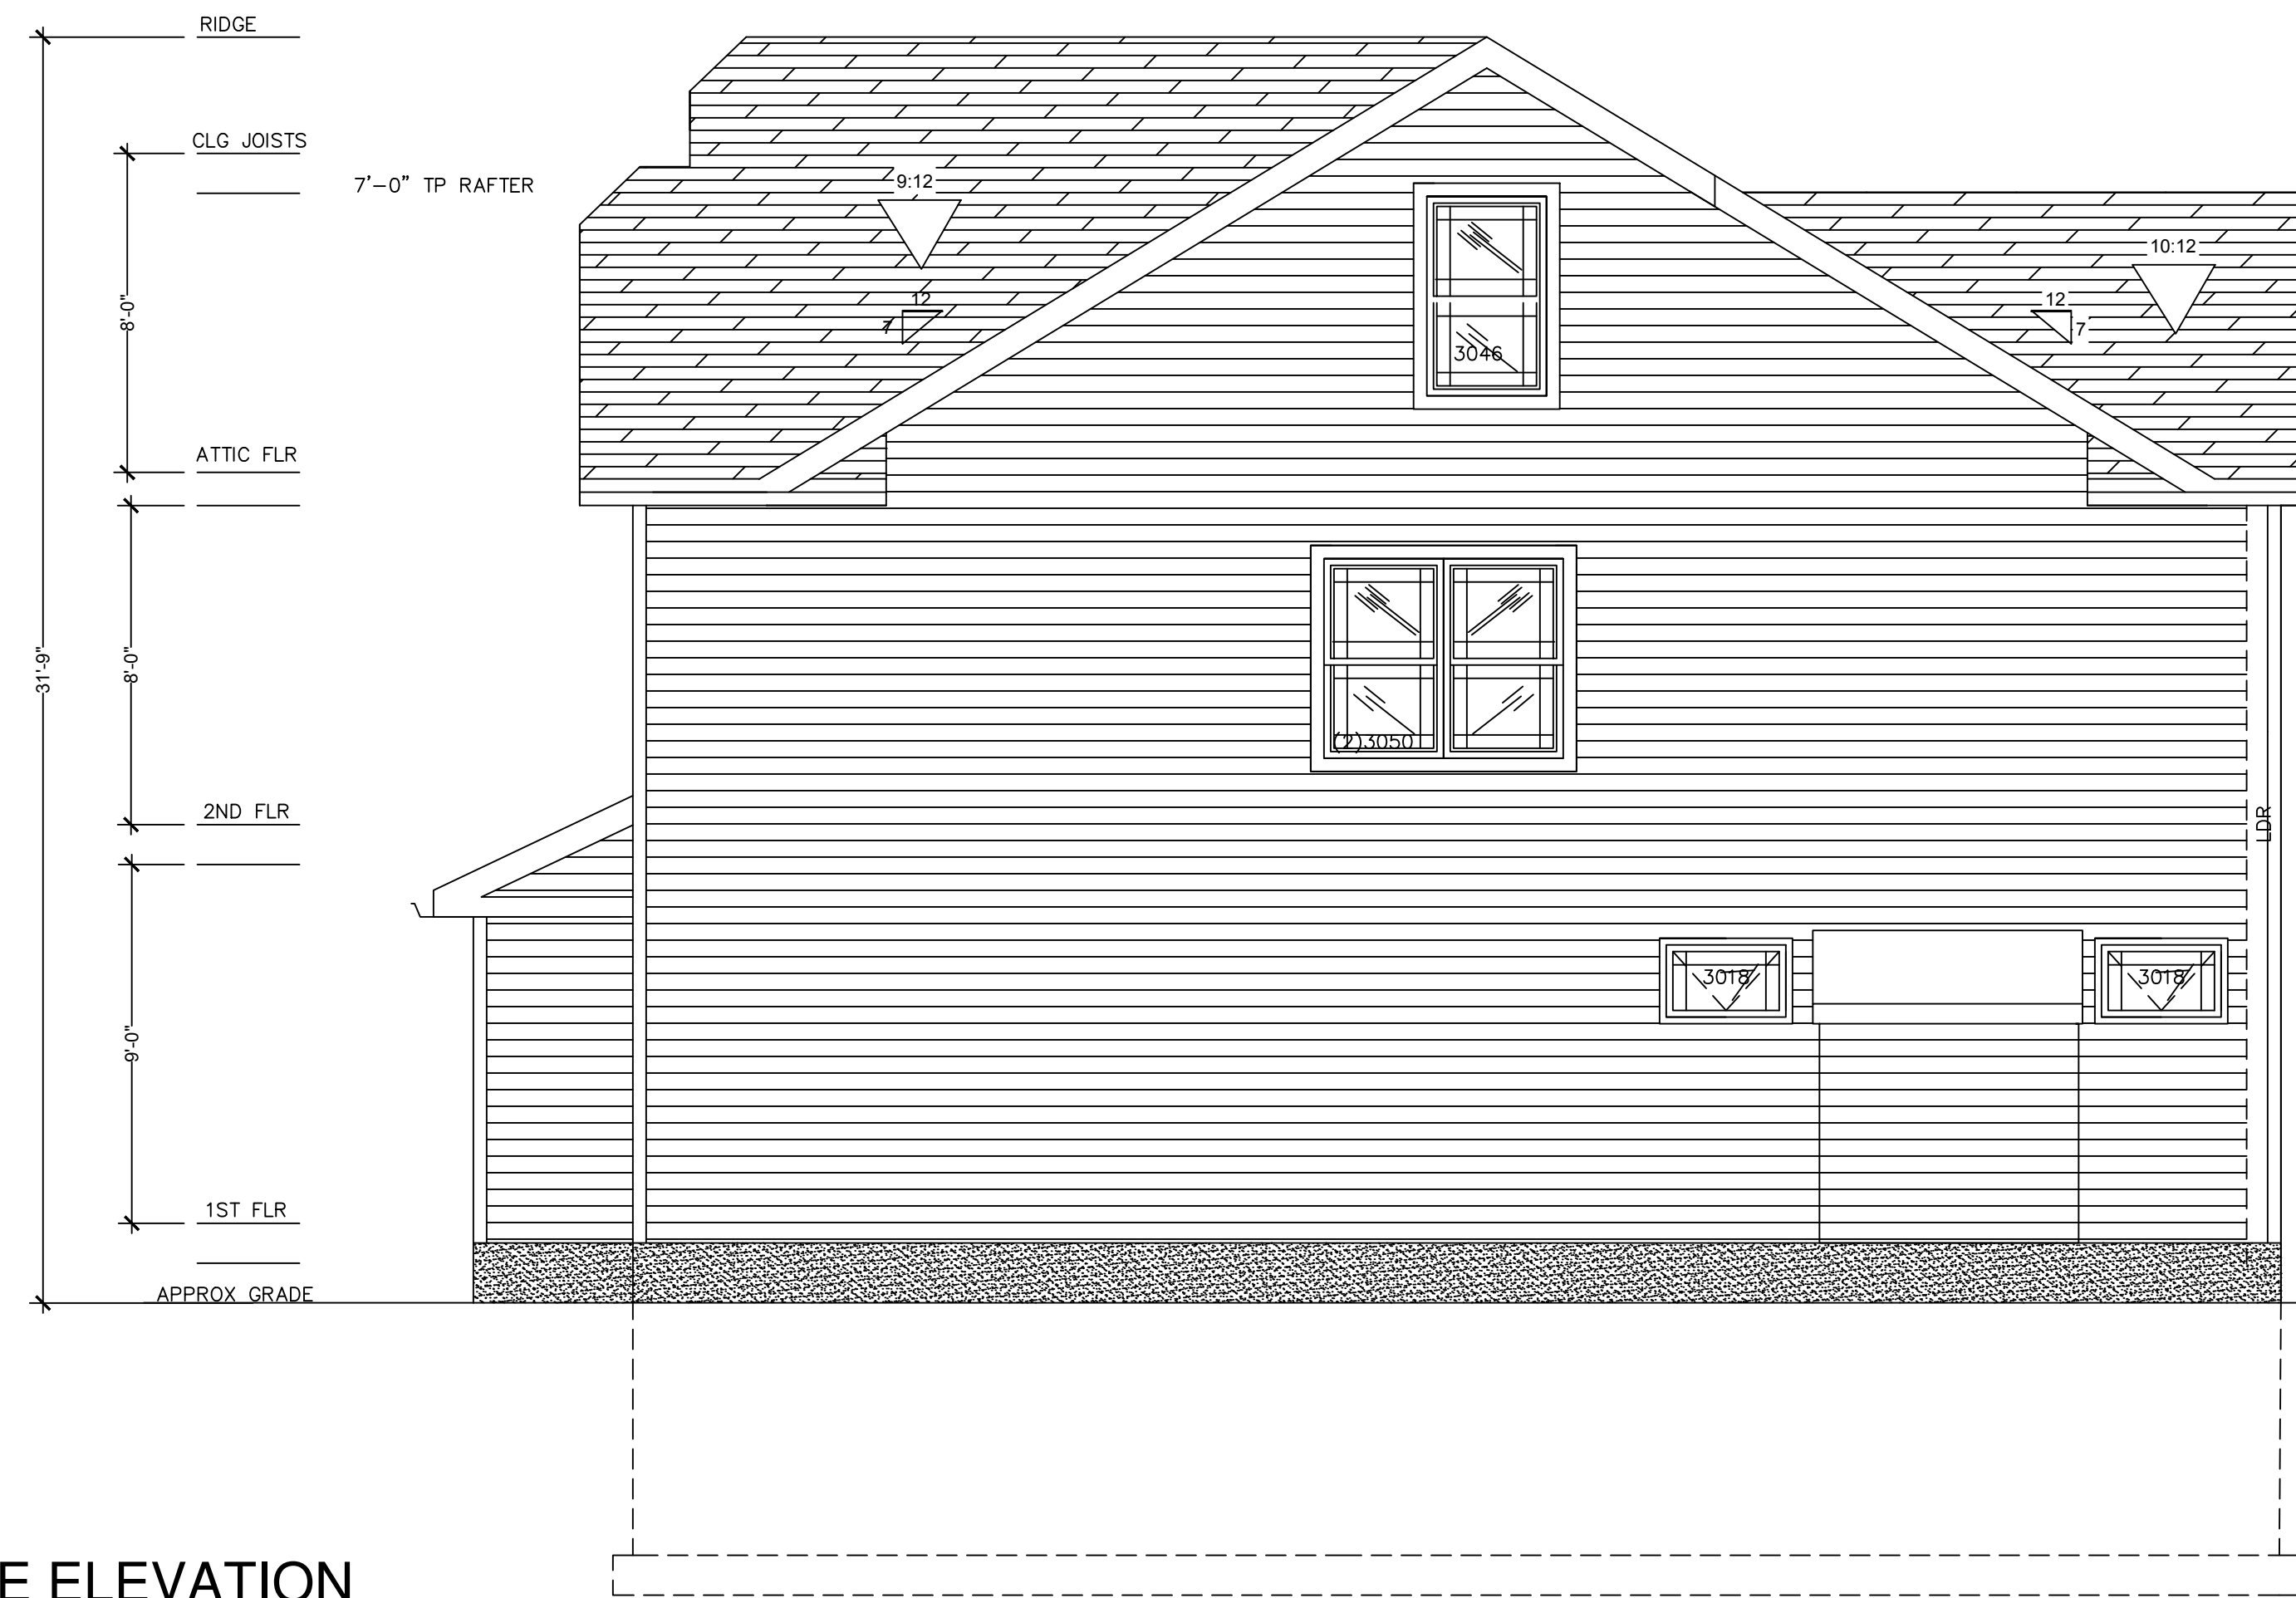

RIGHT SIDE ELEVATION
Scale: 1/4" = 1'-0"

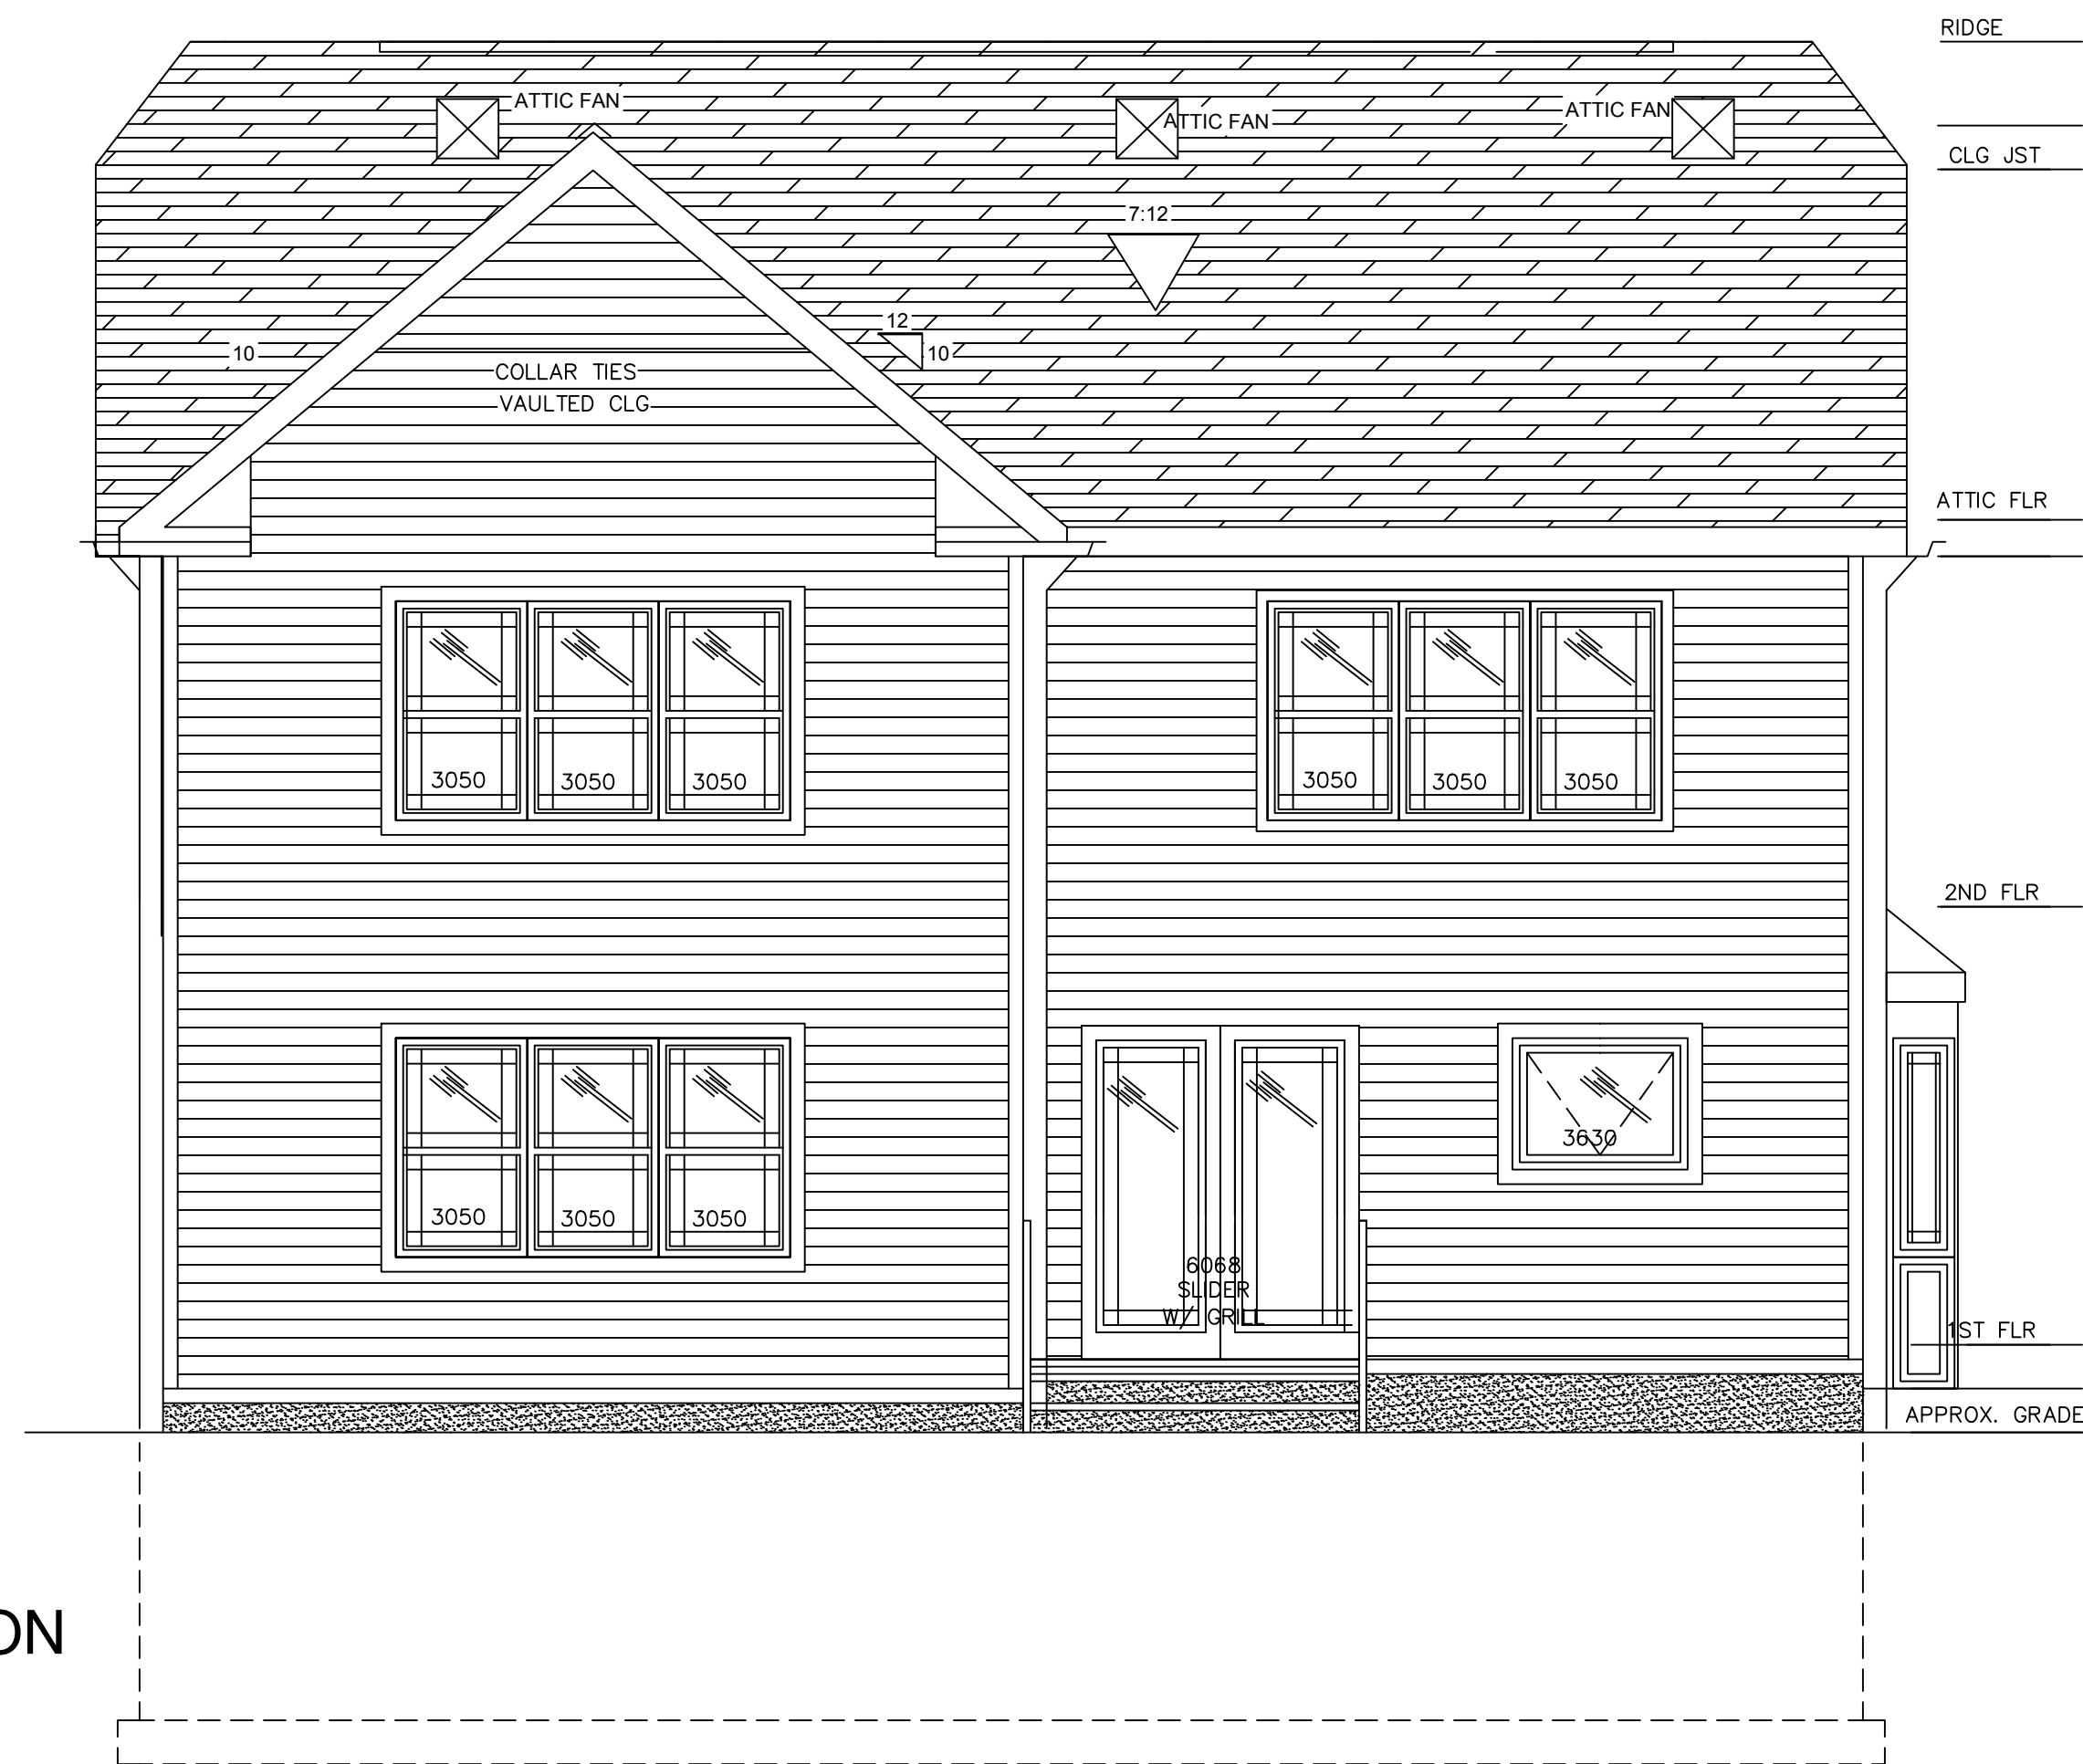

REAR ELEVATION
Scale: 1/4" = 1'-0"



LEFT SIDE ELEVATION
Scale: 1/4" = 1'-0"

DESIGNER:
ARCHITECT

BRICK CITY RECONSTRUCTION
DESIGN-BUILD-REPAIR-MAINTENANCE
RIVERFRONT PLAZA #200291
NEWARK, NJ 07102
F. 201-683-7277 P. 908-902-9592

PATRICK M. LESBIREL
ARCHITECT
NJ LICENSE NO. A120605

SUBMISSIONS		
NO.	DESCRIPTION	DATE

THESE DRAWINGS, OR PARTS THEREOF, MAY NOT BE UTILIZED OR REPRODUCED IN ANY FORM, BY ANY METHOD, FOR ANY PURPOSE, WITHOUT THE PRIOR WRITTEN CONSENT FROM PATRICK M. LESBIREL, ARCHITECT. THESE DRAWINGS SHALL ONLY BE USED FOR THE SPECIFIC PROJECT LOCATION INDICATED WITHIN THE TITLE BLOCK.

REVISIONS		
NO.	DESCRIPTION	DATE

PROJECT:
LOCUST STREET

LOCATION:
ABERDEEN, NJ

TITLE:
ELEVATIONS

SCALE: AS NOTED
DATE: 1.6.16
DRAWN: P.M.L.
CHECKED: P.V.G.
JOB No.: 15247
SHEET: 4 OF 4

DRAWING:
A-04