


2 SECOND FLOOR HVAC LAYOUT
1/4"=1'-0"

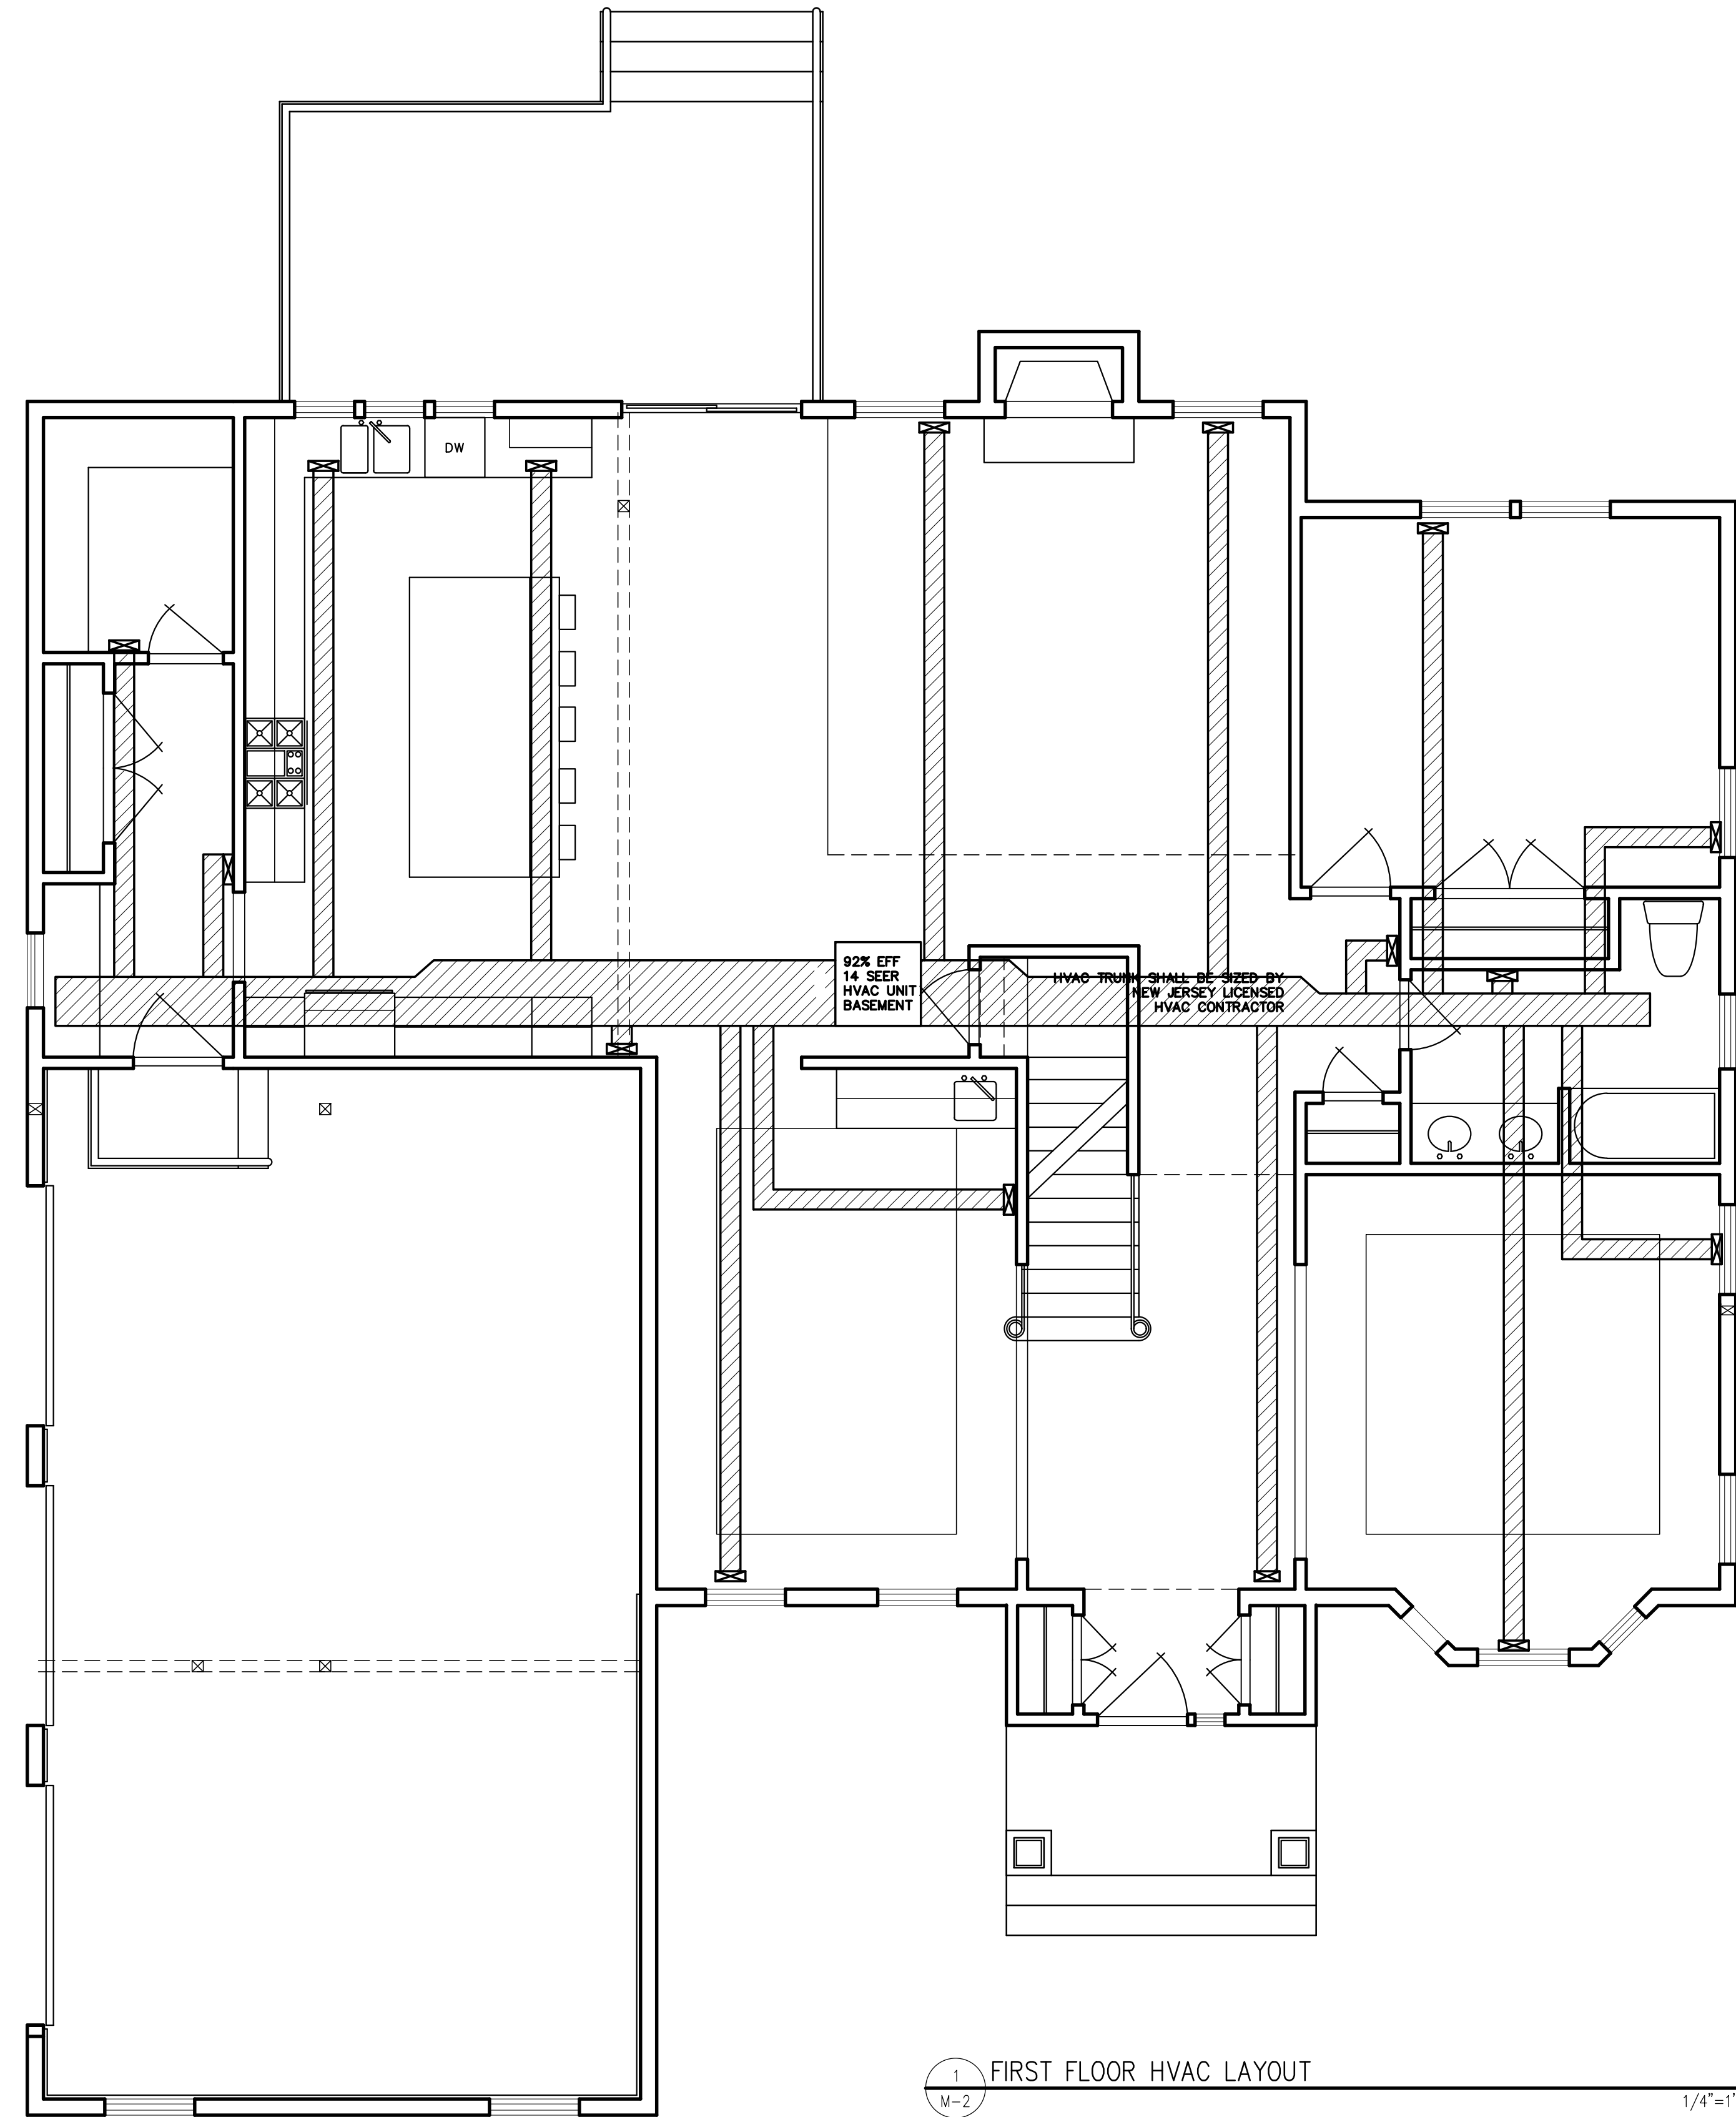

1 FIRST FLOOR HVAC LAYOUT
1/4"=1'-0"

BUILDING DEPARTMENT INFO		
	EXISTING	PROPOSED ADDITIONS
USE GROUP	R-5	R-5
CONSTRUCTION CLASS	5B	5B
SQUARE FOOTAGE	SEE COVER SHEET	
VOLUME	SEE COVER SHEET	
OCCUPANCY LOAD	SEE COVER SHEET	
AREA OF LARGEST FLOOR (SF)	SEE COVER SHEET	

DESIGN LOAD TABLE:	
FIRST FLOOR:	50 PSF LIVE 10 PSF DEAD
SECOND FLOOR:	40 PSF LIVE 10 PSF DEAD
ROOF:	30 PSF LIVE 10 PSF DEAD
WIND:	100 MPH (ASSUMED)

ZONING DATA:	
MUNICIPALITY	MARLBORO, NEW JERSEY
LOT NO	78.01
BLOCK NO.	153
ZONE	R-80

SCOPE OF WORK:
ARCHITECTURAL PROPOSAL FOR:
NEW 2 STORY SINGLE FAMILY HOME.

ROBERT A. HERNANDEZ ARCHITECT LLC
267 AMBOY AVENUE, SUITE 30, METUCHEN, NJ 08840
TEL: (732)372-7955 FAX: (208)730-6888
EMAIL: NJARCHITECT@GMAIL.COM

CLIENT NAME:
ESK BUILDER INC.
CLIENT ADDRESS:
136 BEACON HILL ROAD MARLBORO, NEW JERSEY LOT: 78.01 BLOCK: 153
CLIENT CONTACT INFORMATION:
TELEPHONE: (732) 275-7789 MICHAEL KONTOS

THIS DOCUMENT IS THE EXCLUSIVE PROPERTY OF ROBERT A. HERNANDEZ ARCHITECT. THE CONSTRUCTION DOCUMENTS AND INFORMATION CONTAINED WITHIN MAY NOT BE REPRODUCED OR USED FOR ANY PURPOSES, OTHER THAN FOR THE SPECIFIC PROJECT FOR WHICH IT WAS PREPARED WITHOUT THE EXPRESS CONSENT FROM ROBERT A. HERNANDEZ ARCHITECT.

REVISION #	REVISION DATE
REVISION 2	MARCH 13, 2018
REVISION 1	FEBRUARY 2, 2018
REVISION #	REVISION DATE

DWGS ON THIS SHEET: ROBERT A. HERNANDEZ ARCHITECT

DATE: JANUARY 9, 2018	N.J. Reg. No. 18706 Cert. of Auth. AC-919 (NOT VALID UNLESS SEALED)
SCALE: AS SHOWN	
DRAWN BY R.A.H.	
CHECKED BY R.A.H.	
PROJECT NUMBER 16-049	

M-2
SHEET: 11 OF 16